


THIS DESIGN IS PROTECTED BY A COPYRIGHT. ANY USE OR REPRODUCTION OF THIS MATERIAL MUST BE WITH THE EXPRESSED WRITTEN CONSENT OF JDW DESIGNS

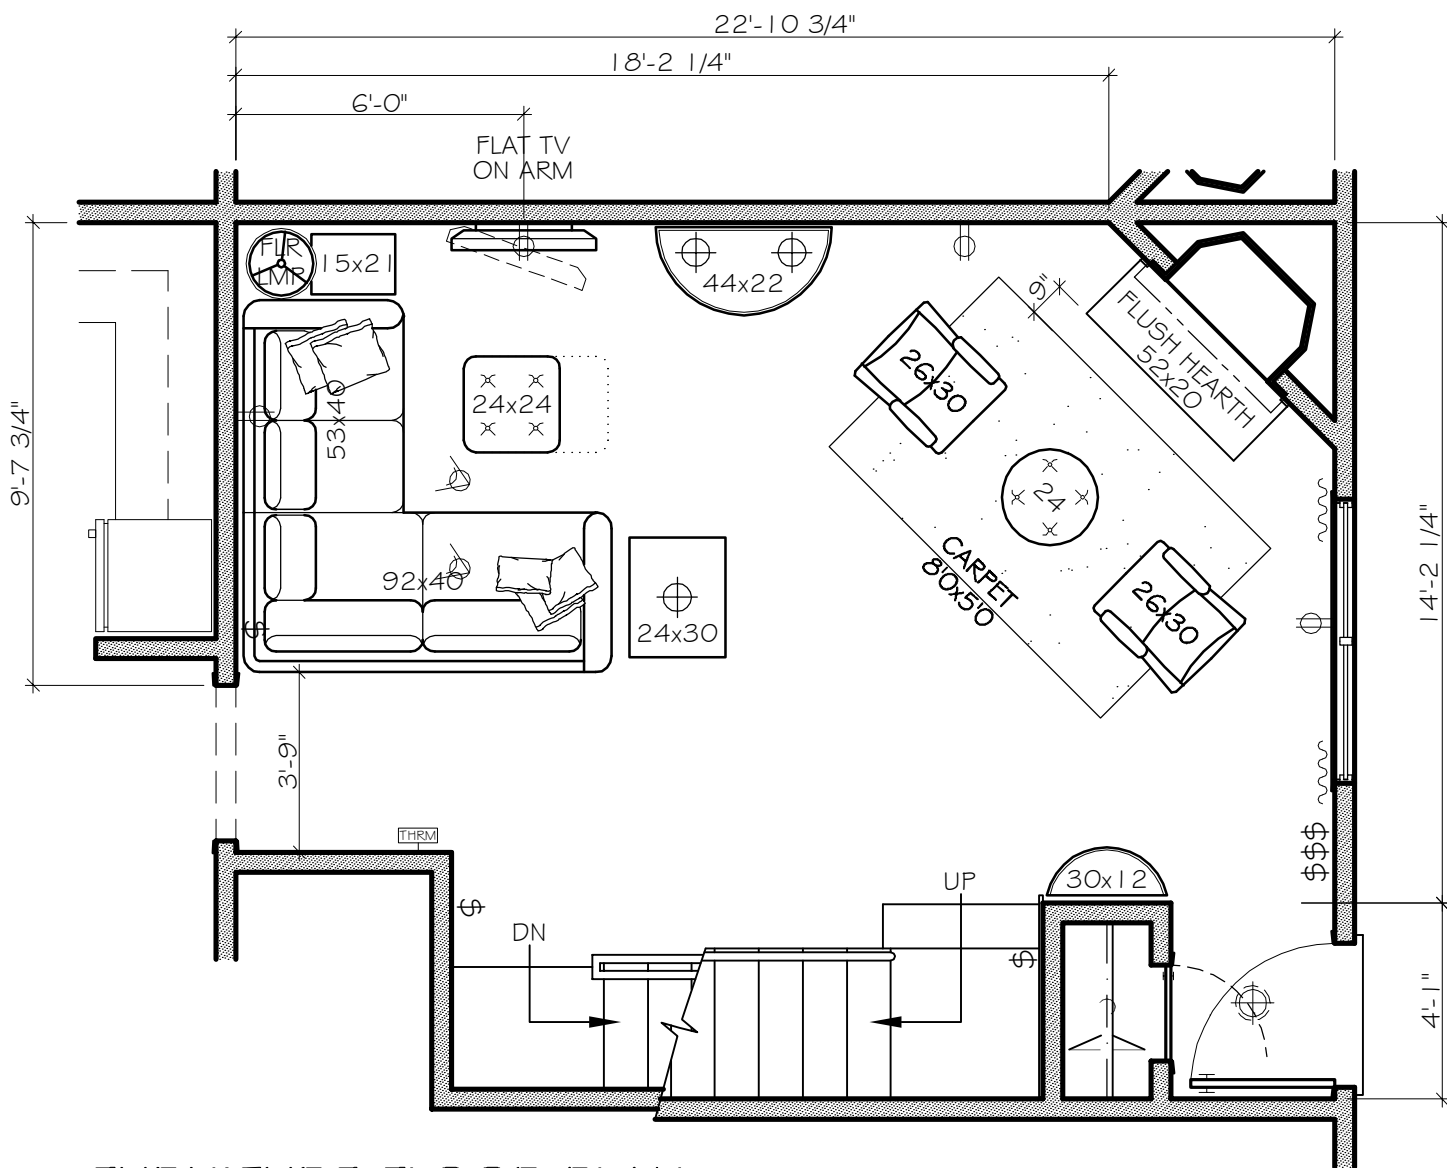

SYMBOL KEY

	SURFACE MOUNTED
	DOWN WASH EYEBALL
	OUTLET
	LIGHT SWITCH
	THERMOSTAT

ALL EXISTING

ROTATE DOWNWASH LIGHTS TO HIGHLIGHT WALL FOR ARTWORK
SEE FIREPLACE ELEVATION EL-101 FOR PROPOSED SCONCES

2	7/12/10	FIRST PROPOSAL
1	7/12/10	DONNA-CLIFTON
No.	Date	Revisions

J.D.W.
J.D.W. DESIGNS
Suite 8-A
45 Church Street
Montclair, NJ 07042
P:973.783.7701 ~ F:973.783.7702

PROJECT
CLIENT RESIDENCE
CLIENTVILLE, NEW JERSEY

TITLE
FURNITURE FLOOR PLAN
MAIN LEVEL LIVING ROOM

Date:	7/12/10	DRAWING NUMBER	Issue
Dwg. By:	JDP	FP-100	2
Scale:	AS NOTED		

FURNITURE FLOOR PLAN

1/4" = 1'-0" ~ MAIN LEVEL LIVING ROOM

PRELIMINARY
FOR CONCEPT PURPOSES ONLY!
CONTRACTORS TO VERIFY ALL DIMENSIONS.

7/25/2011 1:25:38 PM